


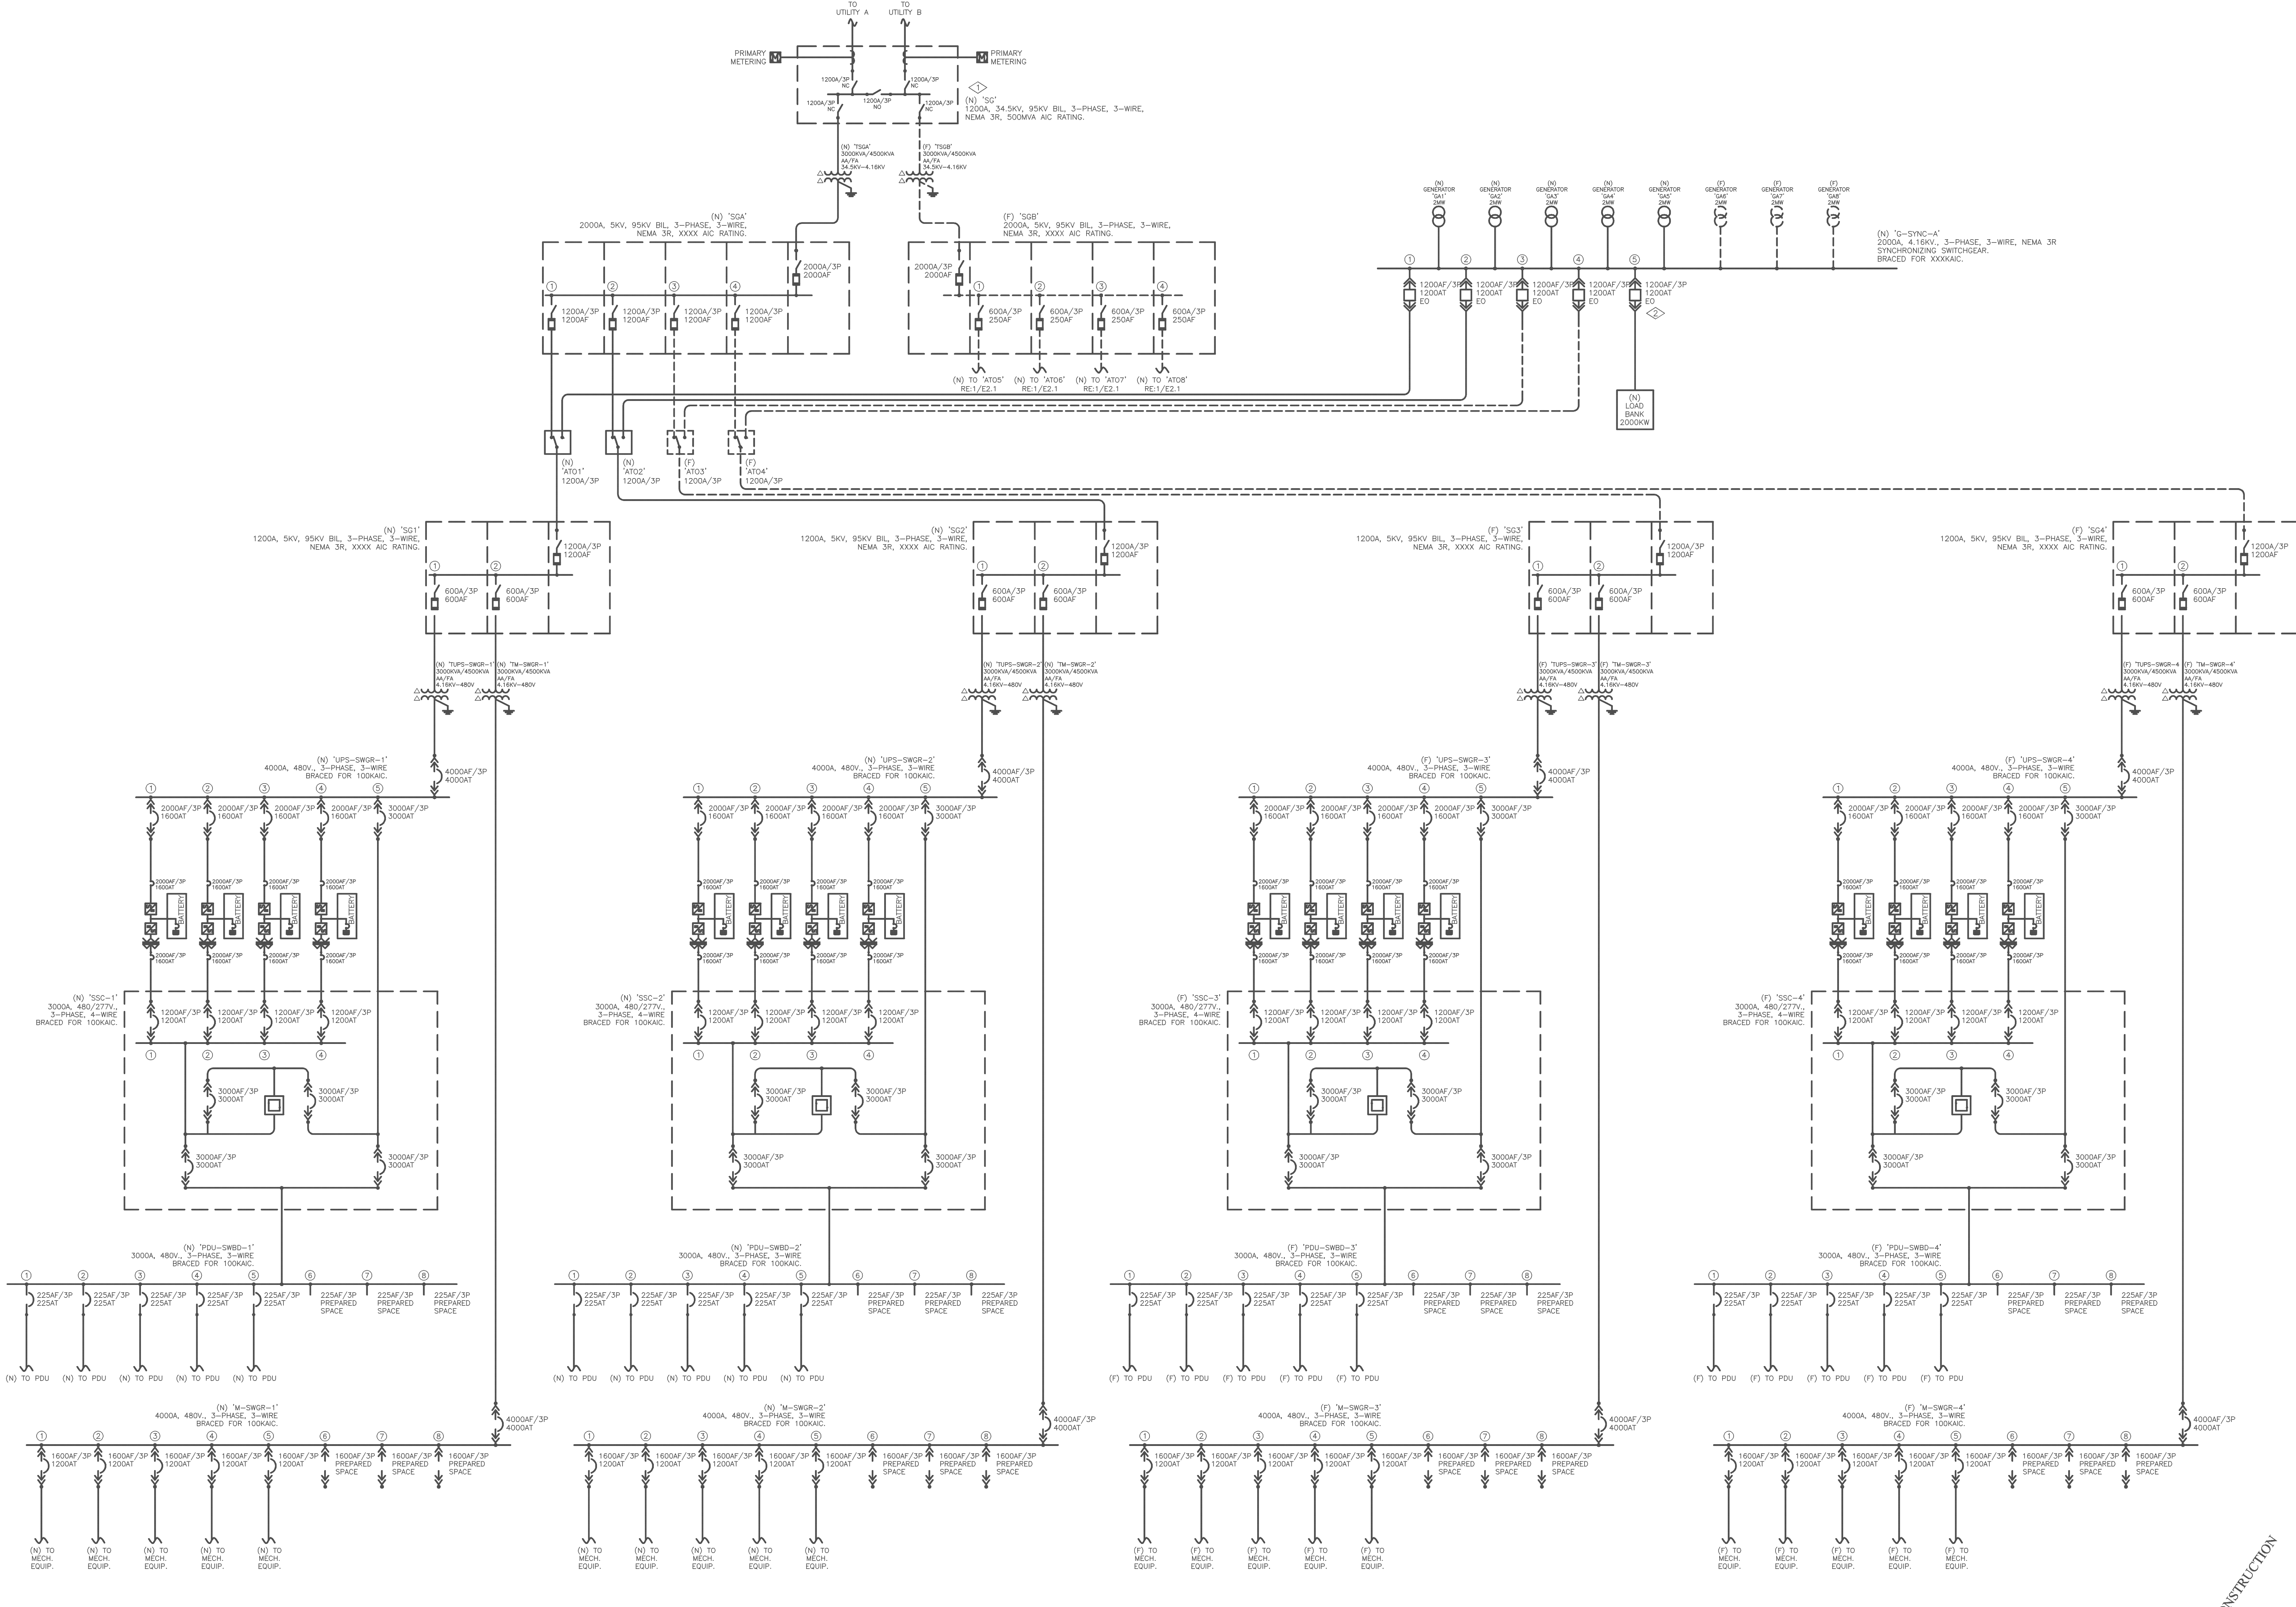

1 ONE-LINE DIAGRAM
E2.0 SCALE: NONE

GENERAL NOTES:

- 1. ELECTRICAL EQUIPMENT SHOWN IN HEAVY/CONTINUOUS PEN WEIGHT IS NEW AND HEAVY/DASHED PEN WEIGHT IS FUTURE, UNLESS OTHERWISE NOTED.

DETAILED NOTES:

- 1. ELECTRICAL EQUIPMENT SHOWN IN HEAVY/CONTINUOUS PEN WEIGHT IS NEW AND HEAVY/DASHED PEN WEIGHT IS FUTURE, UNLESS OTHERWISE NOTED.
- 2. FEEDER BREAKER TO LOAD BANK CAN BE USED AS A SPARE FEEDER BREAKER.



NOT FOR CONSTRUCTION

ELECTRICAL AND MECHANICAL
CONSULTING ENGINEERS

POWER ENGINEERING

EG

4855 Ward Road, Suite 600
Whittier Ridge, Colorado 80033
Phone: (720) 534-8851
Fax: (720) 534-8851
Website: www.egpower.com

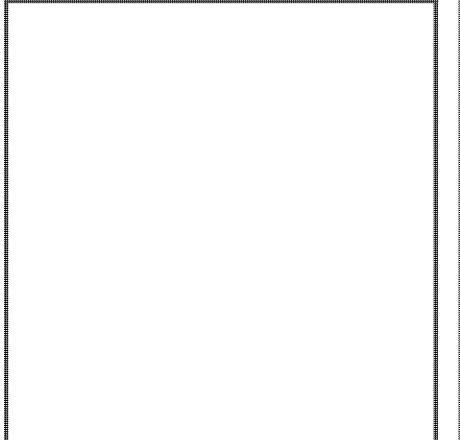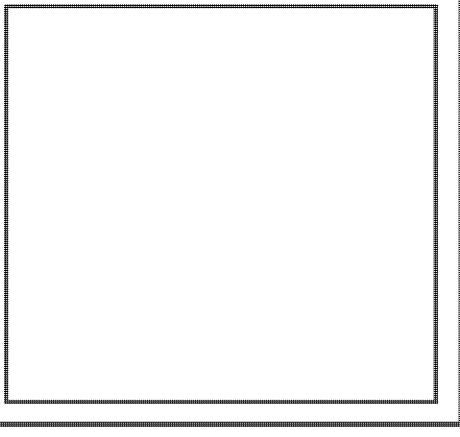

Switch and Data

TENANT IMPROVEMENT

900 NORTH ALAMEDA STREET
LOS ANGELES, CA

DATE	DESCRIPTION	BY
10-10-07	CONCEPT DRAWINGS	EIG
11-20-07	PROGRESS DRAWINGS	EIG

SHEET TITLE:
ONE-LINE DIAGRAM

DATE:
10-10-07

PROJECT NO.:
EGP040000.00

SHEET NO.
E20